

A.01 MAIN ID WEST ENTRY


Job Number
78640



A A.01 - Main ID - West Elevation View
SCALE : 1/32" = 1' - 0'

TURNER CONSTRUCTION COMPANY
Reviewed for General Acceptance only. This review does Not relieve the subcontractor of the responsibility for making the work conform to the requirements of the contract. The subcontractor is responsible for all dimensions, correct fabrication and accurate fit with the work of other trades.

SUBMITTAL #0705-10 14 25-01
BY: Martha Leahy DATE: 04/25/2011

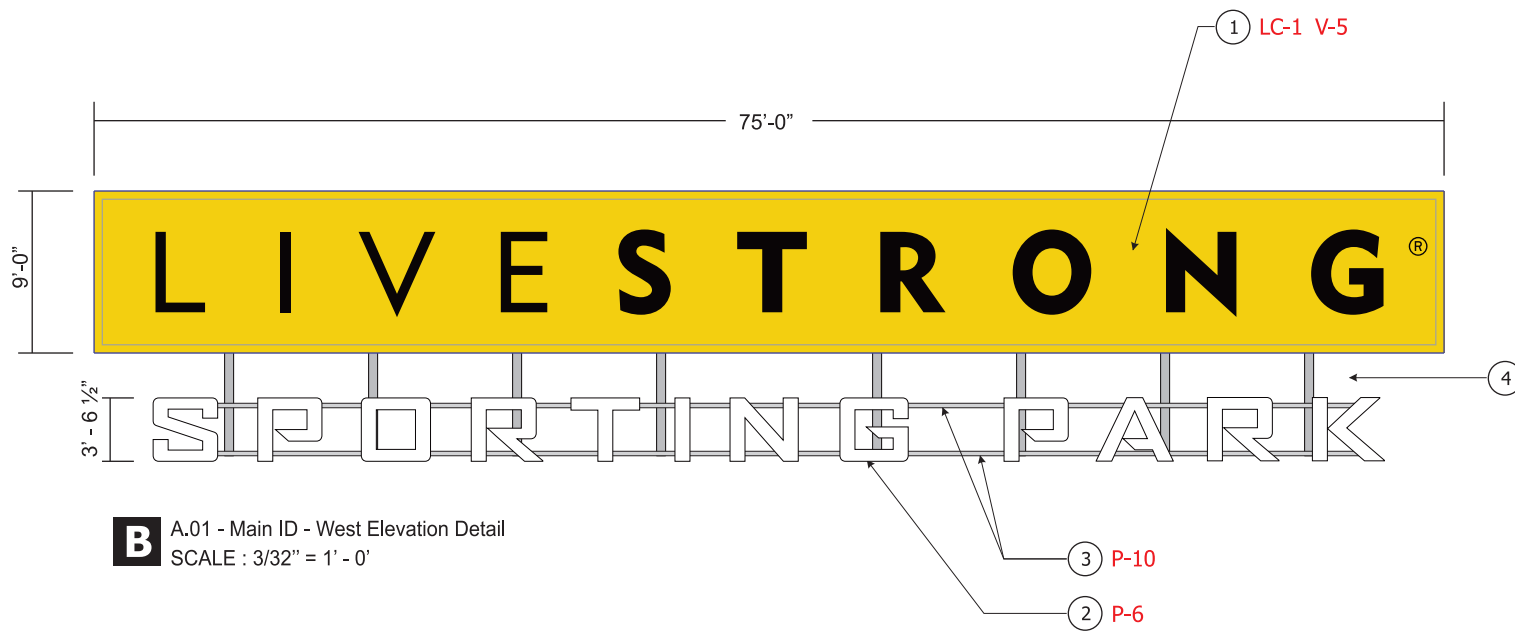

B A.01 - Main ID - West Elevation Detail
SCALE : 3/32" = 1' - 0'



C NIGHT VIEW
SCALE : NTS

1. RECTANGULAR CABINET "LIVESTRONG" IS TO BE CONSTRUCTED OF STEEL ANGLE WITH FLEX FACES. CABINET HAS A RADIUS OF 547' - 2 1/2" ON BACK. FLEX FACE IS TO BE DIGITALLY PRINTED **LC-1** YELLOW AND OPAQUE BLACK **V-5** VINYL GRAPHICS. MOUNT CABINET WITH ROLLED HORIZONTAL TUBES. SEE LETTER DETAIL (PG 23b.1 - .2) FOR SPECIFICATIONS.
2. "SPORTING PARK" LETTERS ARE TO BE FACE-LIT WITH #2447 WHITE ACRYLIC. FACE, RETURNS, BACKS AND TRIM-CAP ARE TO BE WHITE. SEE LETTER DETAIL (PG 23b.1) FOR SPECIFICATIONS. LETTERS ARE MOUNTED TO ROLLED HORIZONTAL TUBES AND THEN MECHANICALLY FASTENED TO STRUCTURE.
3. HORIZONTAL RADIUS TUBING BEHIND LETTERS IS TO BE 3" x 3" x 1/4" ALUMINUM ROLLED SQUARE TUBE PAINTED TO MATCH MULLIONS OF THE EXISTING WINDOWS. COLOR TBD. THE VERTICAL SUPPORTS ARE EXISTING AND WILL BE LOCATED DIRECTLY IN FRONT OF THE VERTICAL WINDOW MULLIONS APPROXIMATELY 8'-0" O.C. (12' SPACE AT CENTER) SURVEY SPACING OF EXISTING VERTICAL TUBING PRIOR TO FABRICATION FOR PROPER ALIGNMENT.
4. VERTICAL BARS ARE DONE BY OTHERS AND ARE TO BE USED TO MECHANICALLY FASTEN SIGN STRUCTURES TO AND TO RUN POWER THROUGH AS REQUIRED PAINTED **P-10**.

PAINT CALL OUTS:

- P-6** MP 27386 VERIZON WHITE
- LC-1** DIGITALLY PRINTED TO MATCH 116c
- V-5** 3M 7725-12 BLACK
- P-10** TBD - MATCH EXISTING WINDOW MULLIONS

Need structural calculations stamped by
PE in state of Kansas.

Job Name: Kansas City Wizards
A.01 MAIN ID WEST ENTRY (QTY: 1)
KC SPORTING

JONES SIGN
1711 Scheuring Road
De Pere, WI 54115
www.jonessign.com
Toll Free: 800-536-7446
Tel: 920-983-6700
Fax: 920-983-9145

| | |
|---|--------------------|
| Quality Grade: 3 | Sheet No. : 23b |
| # of Circuits Req'd: --- | |
| Amp Draw: --- | |
| Voltage: --- | |
| Project Manager: Major Projects Team | |
| Salesman: Mark Mueller | |
| Revison Date: 4/25/11 | |
| Date: 1/07/11 | |
| Drwn By: BRL0M | |